


DEMO NOTES BY SYMBOL: (#)

(THIS DRAWING ONLY)

- 1 REMOVE EXISTING PLUMBING INCLUDING ALL REGISTERS, DIFFUSERS, DAMPERS, HANGERS, INSULATION, ETC.
- 2 REMOVE EXISTING AIR CONDITIONING UNIT IN RS. ENTIRELY INCLUDE ALL PIPING, VALVES, CONTROLS, ETC.
- 3 REMOVE EXISTING BOILER INCLUDING ALL PIPING, VALVES, FITTINGS, CONTROLS, ETC.
- 4 REMOVE EXISTING EXHAUST FAN INCLUDING DAMPER, ROOF CURB, AND ALL ASSOCIATED ACCESSORIES.
- 5 REMOVE EXISTING RELIEF VENT INCLUDING DAMPER AND ALL ASSOCIATED ACCESSORIES.
- 6 REMOVE EXISTING DRAINAGES, BOLTS, AND ALL ASSOCIATED ACCESSORIES.
- 7 REMOVE EXISTING UNIT HEATER INCLUDING ALL PIPING, ACCESSORIES, HANGERS, AND ALL ASSOCIATED ACCESSORIES.
- 8 REMOVE EXISTING BOOSTER HEATER INCLUDING ALL ACCESSORIES.

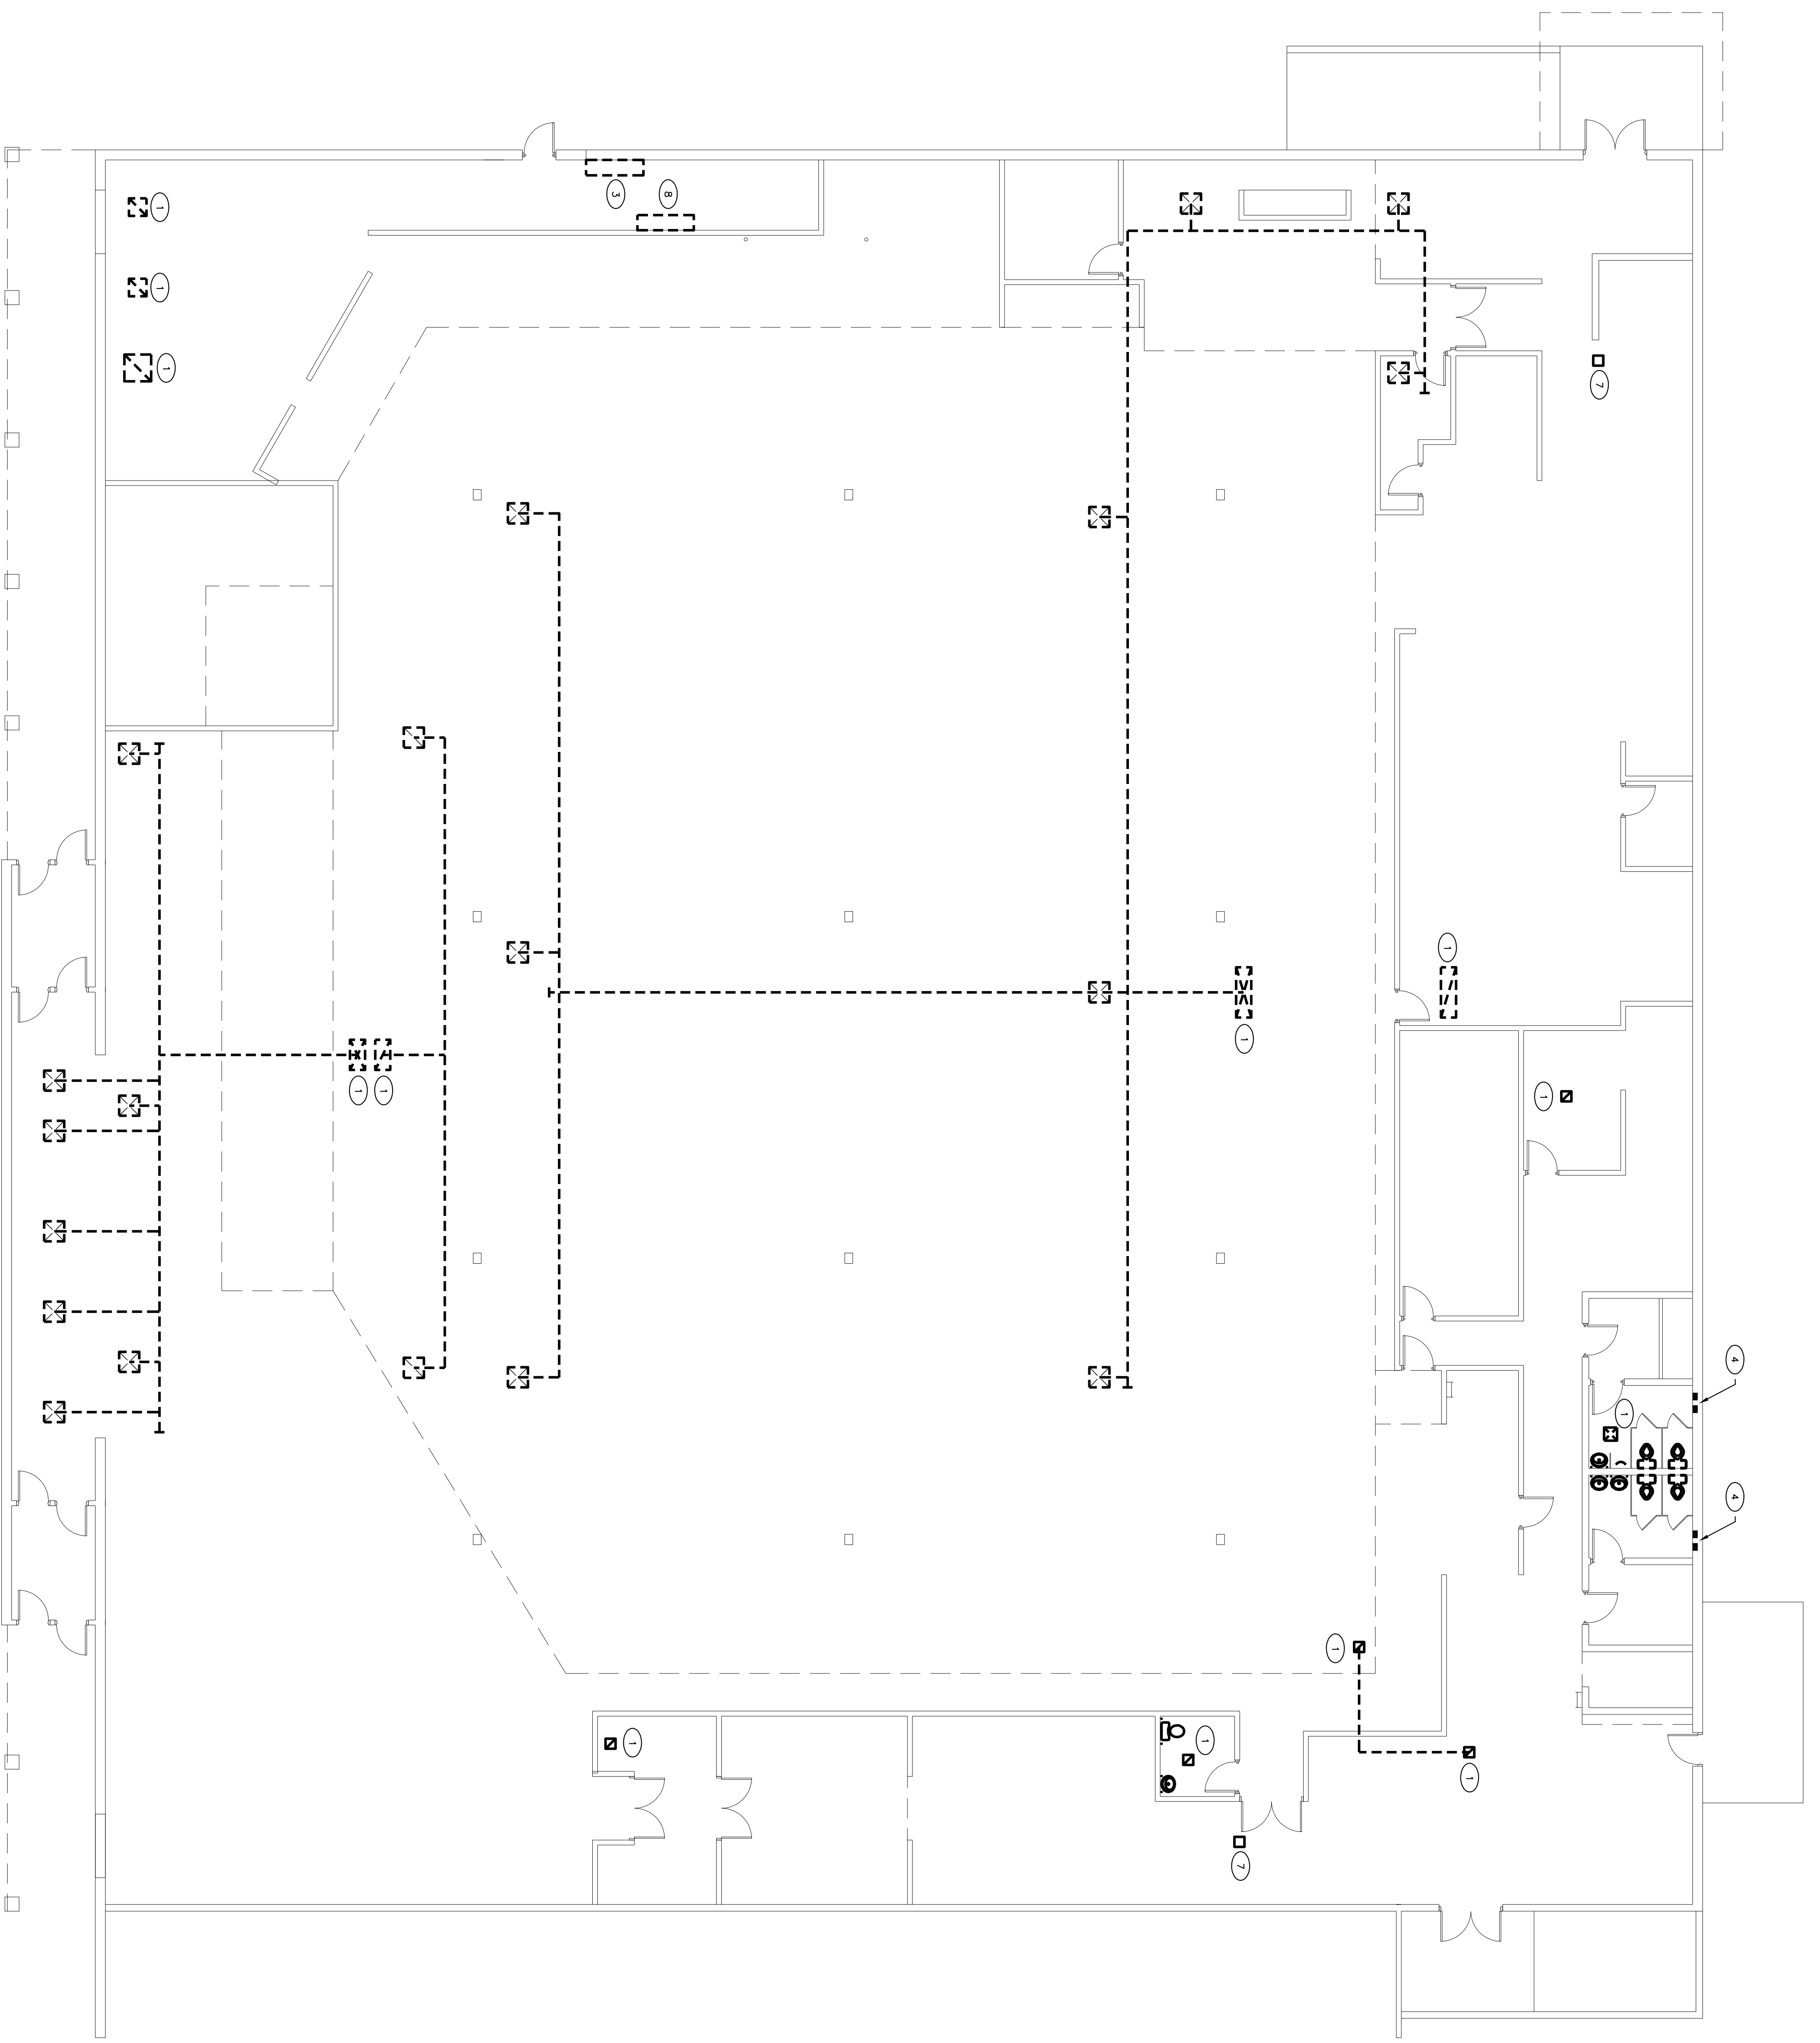

DEMOLITION FLOOR PLAN - HVAC

SCALE: 1/8"=1'-0"

CONSULTANT	BARRETT & ASSOCIATES, INC. Consulting Engineers & Surveyors 1000 N. State St., Suite 200 Toms River, NJ 08753 Phone: 732-885-4141 Fax: 732-885-4142 www.barrett.com															
ARCHITECT	ARCHITECTURAL CONCEPTS LLP Architecture • Planning • Interiors • Engineering The Colonial Mall at Ocean County Center 658 West Lincoln Highway • Eatons Park • Eatons Park Toms River, NJ 08753 Phone: 732-885-4141 Fax: 732-885-4142 www.acconcepts.com															
PROJECT	THE FAVORITES AT TOMS RIVER															
OWNER	BANANIER DRIVE DOVER TOWNSHIP OCEAN COUNTY TOMS RIVER, NJ 08755															
REVISIONS	<table border="1" style="width: 100%; border-collapse: collapse;"> <thead> <tr> <th>No.</th> <th>Date</th> <th>Revision</th> </tr> </thead> <tbody> <tr> <td>09-23-06</td> <td>09-23-06</td> <td>ISSUED FOR BIDDING</td> </tr> <tr> <td>06-04-07</td> <td>06-04-07</td> <td>ISSUED FOR RE-BIDDING</td> </tr> <tr> <td>06-01-07</td> <td>06-01-07</td> <td>ISSUED FOR RE-BIDDING</td> </tr> <tr> <td>09-21-07</td> <td>09-21-07</td> <td>ISSUED FOR CONSTRUCTION</td> </tr> </tbody> </table>	No.	Date	Revision	09-23-06	09-23-06	ISSUED FOR BIDDING	06-04-07	06-04-07	ISSUED FOR RE-BIDDING	06-01-07	06-01-07	ISSUED FOR RE-BIDDING	09-21-07	09-21-07	ISSUED FOR CONSTRUCTION
No.	Date	Revision														
09-23-06	09-23-06	ISSUED FOR BIDDING														
06-04-07	06-04-07	ISSUED FOR RE-BIDDING														
06-01-07	06-01-07	ISSUED FOR RE-BIDDING														
09-21-07	09-21-07	ISSUED FOR CONSTRUCTION														
Sheet Title	HVAC DEMOLITION FLOOR PLAN															
Project Name	RE-SUBMITTED FOR BIDDING															
Issue Date	30 APRIL 2007															
Drawing Scale	AS NOTED															
Designing Firm	ARCHITECTURAL CONCEPTS LLP															
Drawn By	MDK															
Reviewed By	NMS/AMM															
Project No.	114306															
File Name	114306.dwg															
Plot Scale	1/8" = 1'-0"															
Plot Size	30" X 42"															
Sheet No.	H1.1															
Sheet of	1															